


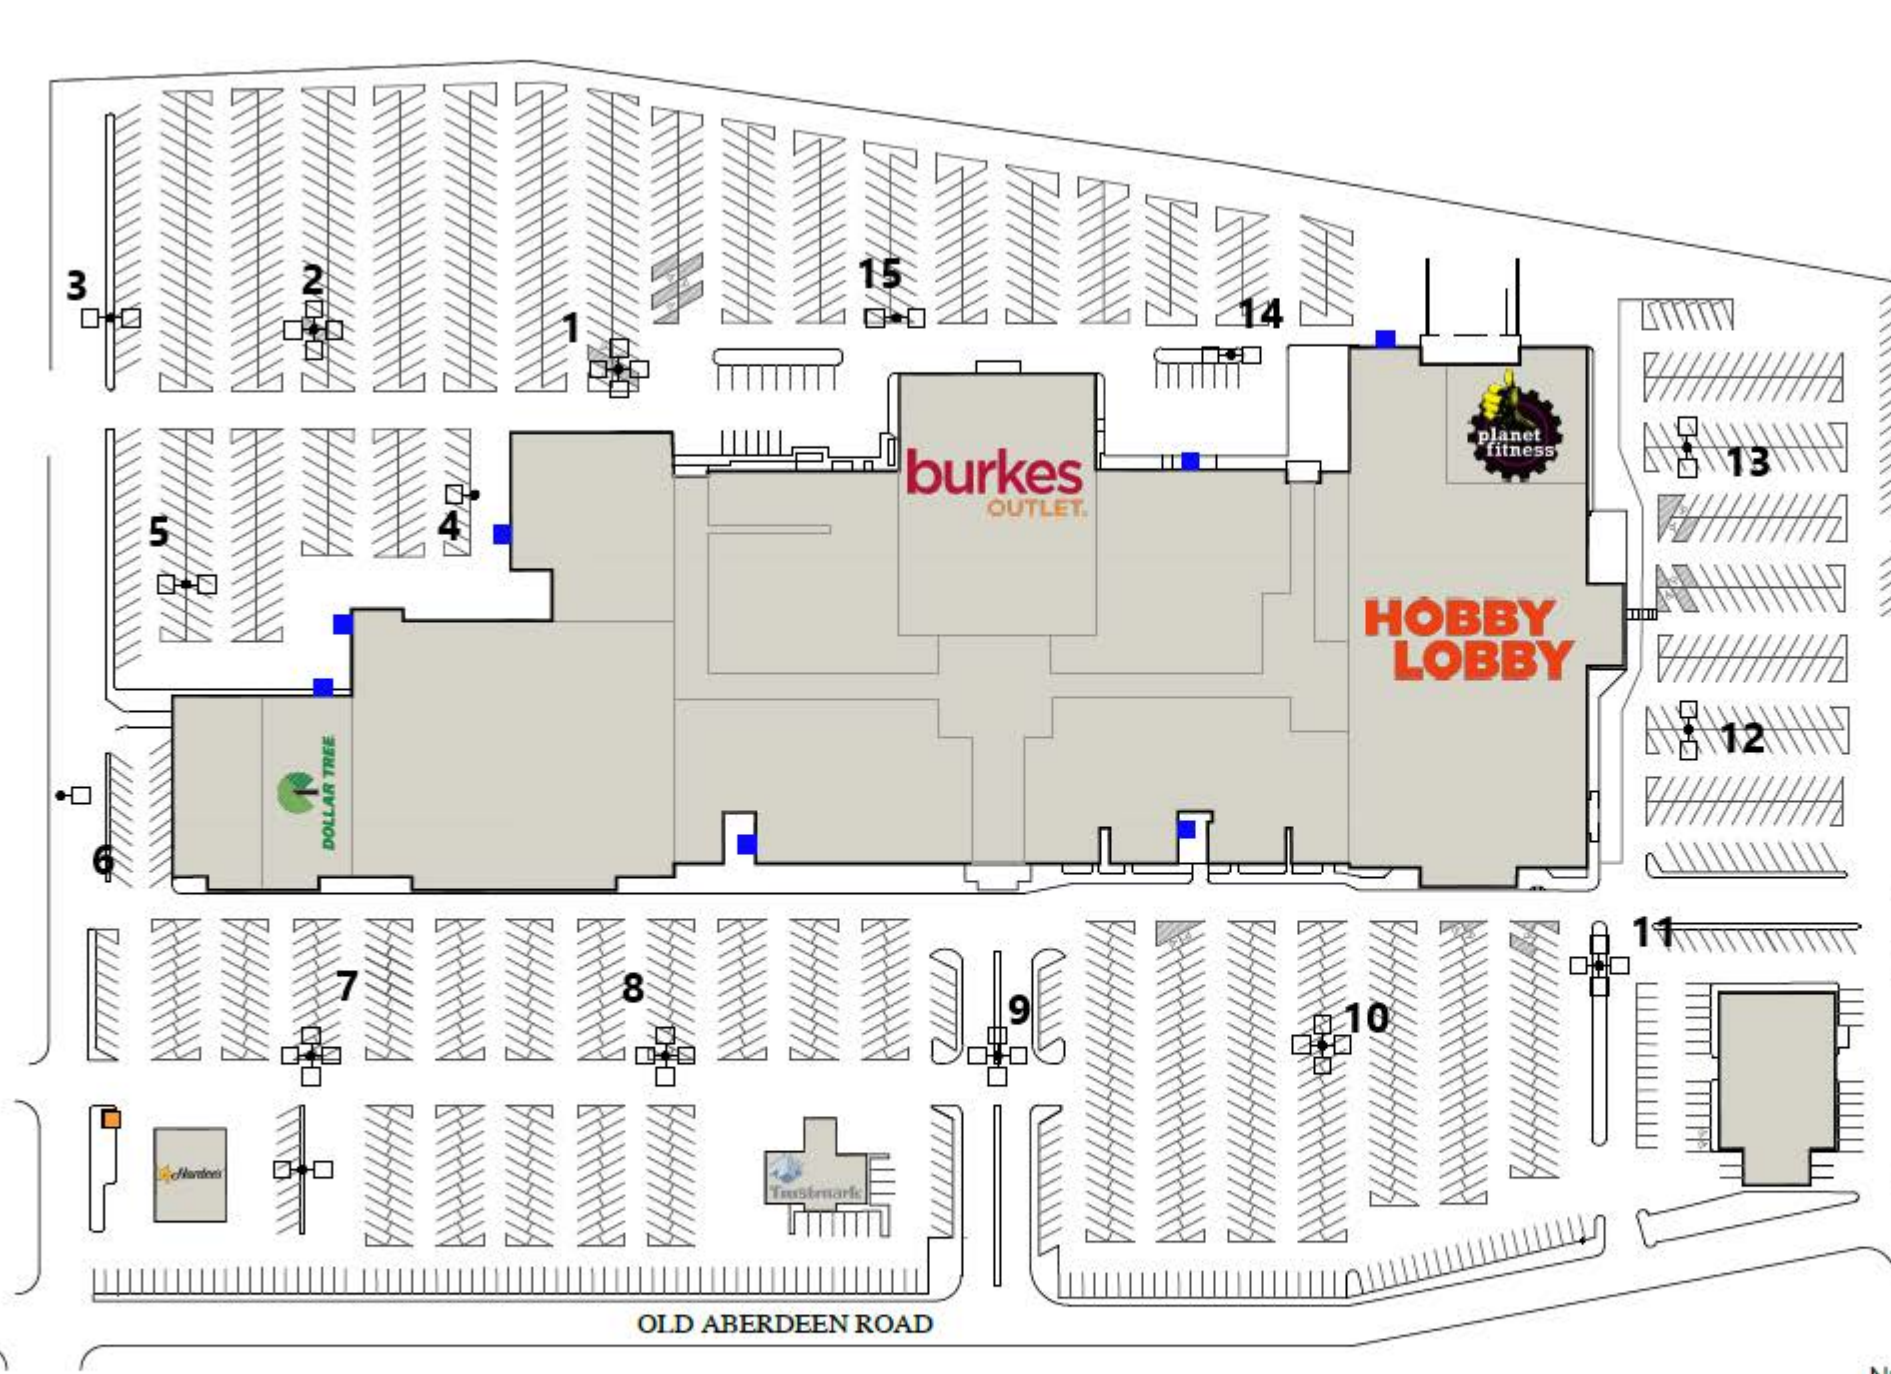

KEY	
NL	NIGHT LIGHT ?
	TRANSFORMERS ?
	PULL BOXES ?
	CONTACTORS ?
	TIME CLOCKS ?
	1000W BT56 MH 480V ?
△	LED WALL PACK 277V ?
○	LED PEDEST. POLES ?
◐	LED SCONCES ?
()	WIRING ?

DATE _____

MANAGER _____

NUMBER OF LIGHTS OUT _____

No.	Description	Date

Leigh Mall

1404 Old Aberdeen Rd.

Columbus, MS

Exterior Lighting Layout

Site Plan

HULL | PROPERTY GROUP

1190 Interstate Parkway, Augusta, GA 30909 | P. 706.863.2222 | www.hullpg.com

Scale _____

Date 07/08/2020

Drawn by H.LAMB

Checked by H.LAMB

Not to Scale

PPG